






1 Substation Building Plan
Scale 1:100 @ A1

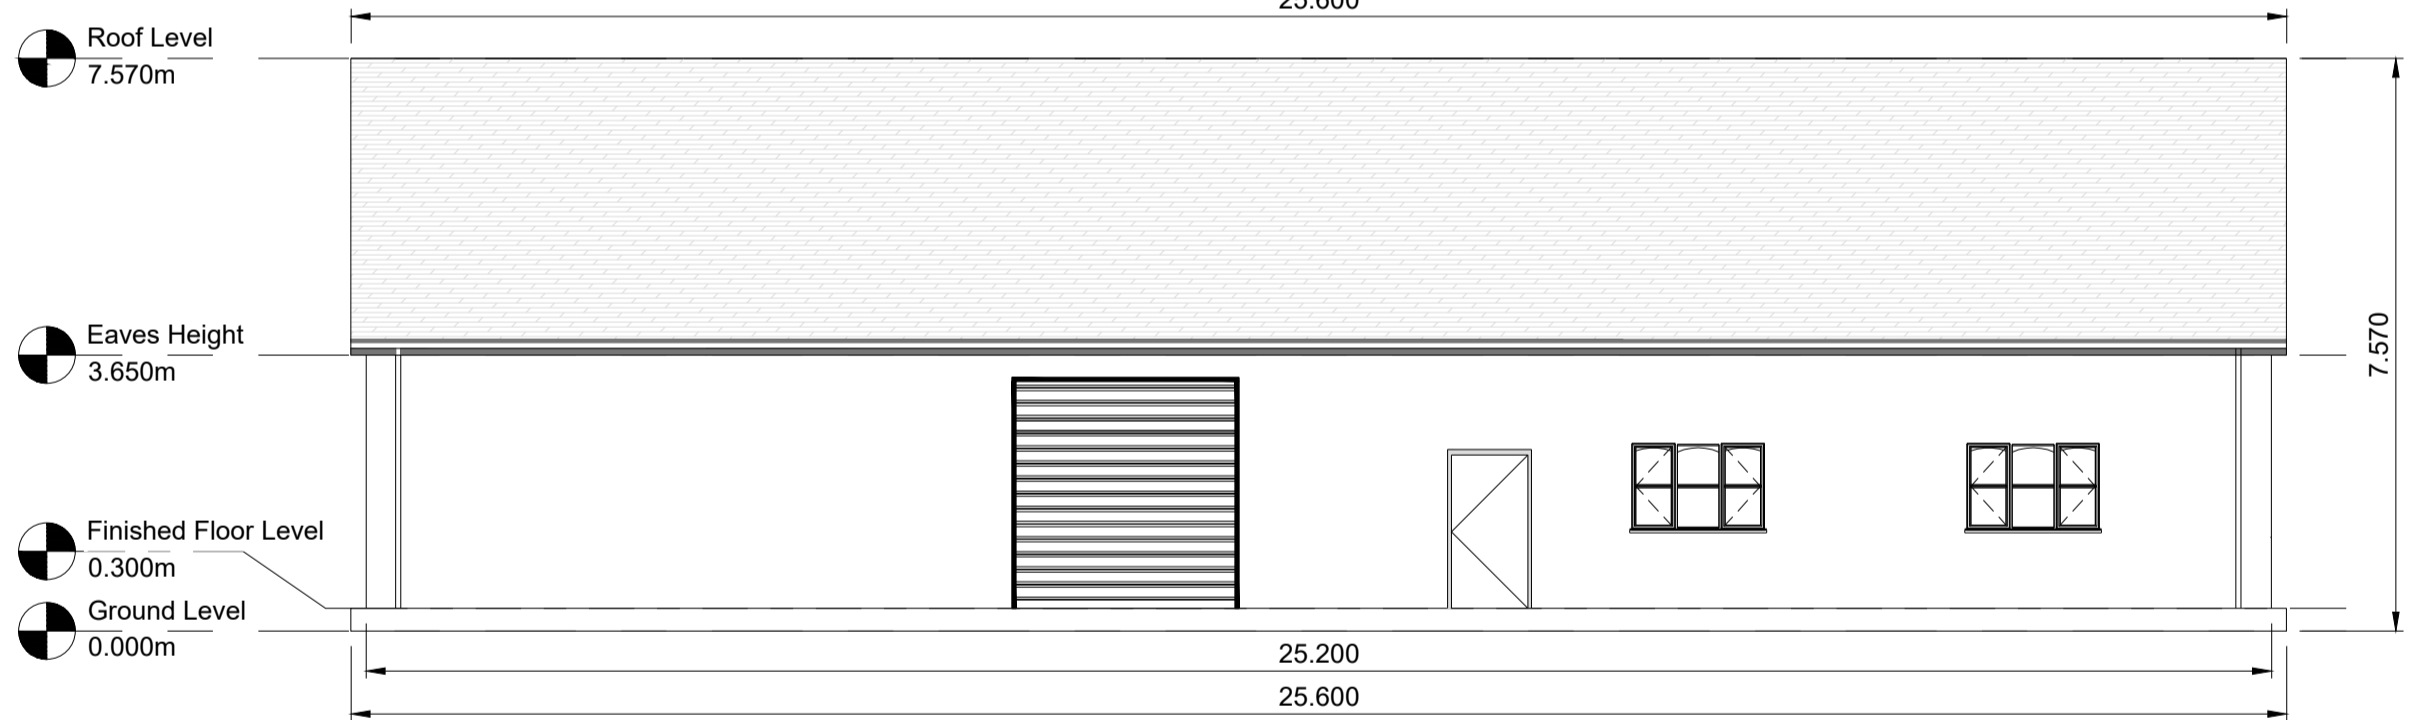


2 Substation Building North Elevation
Scale 1:100 @ A1

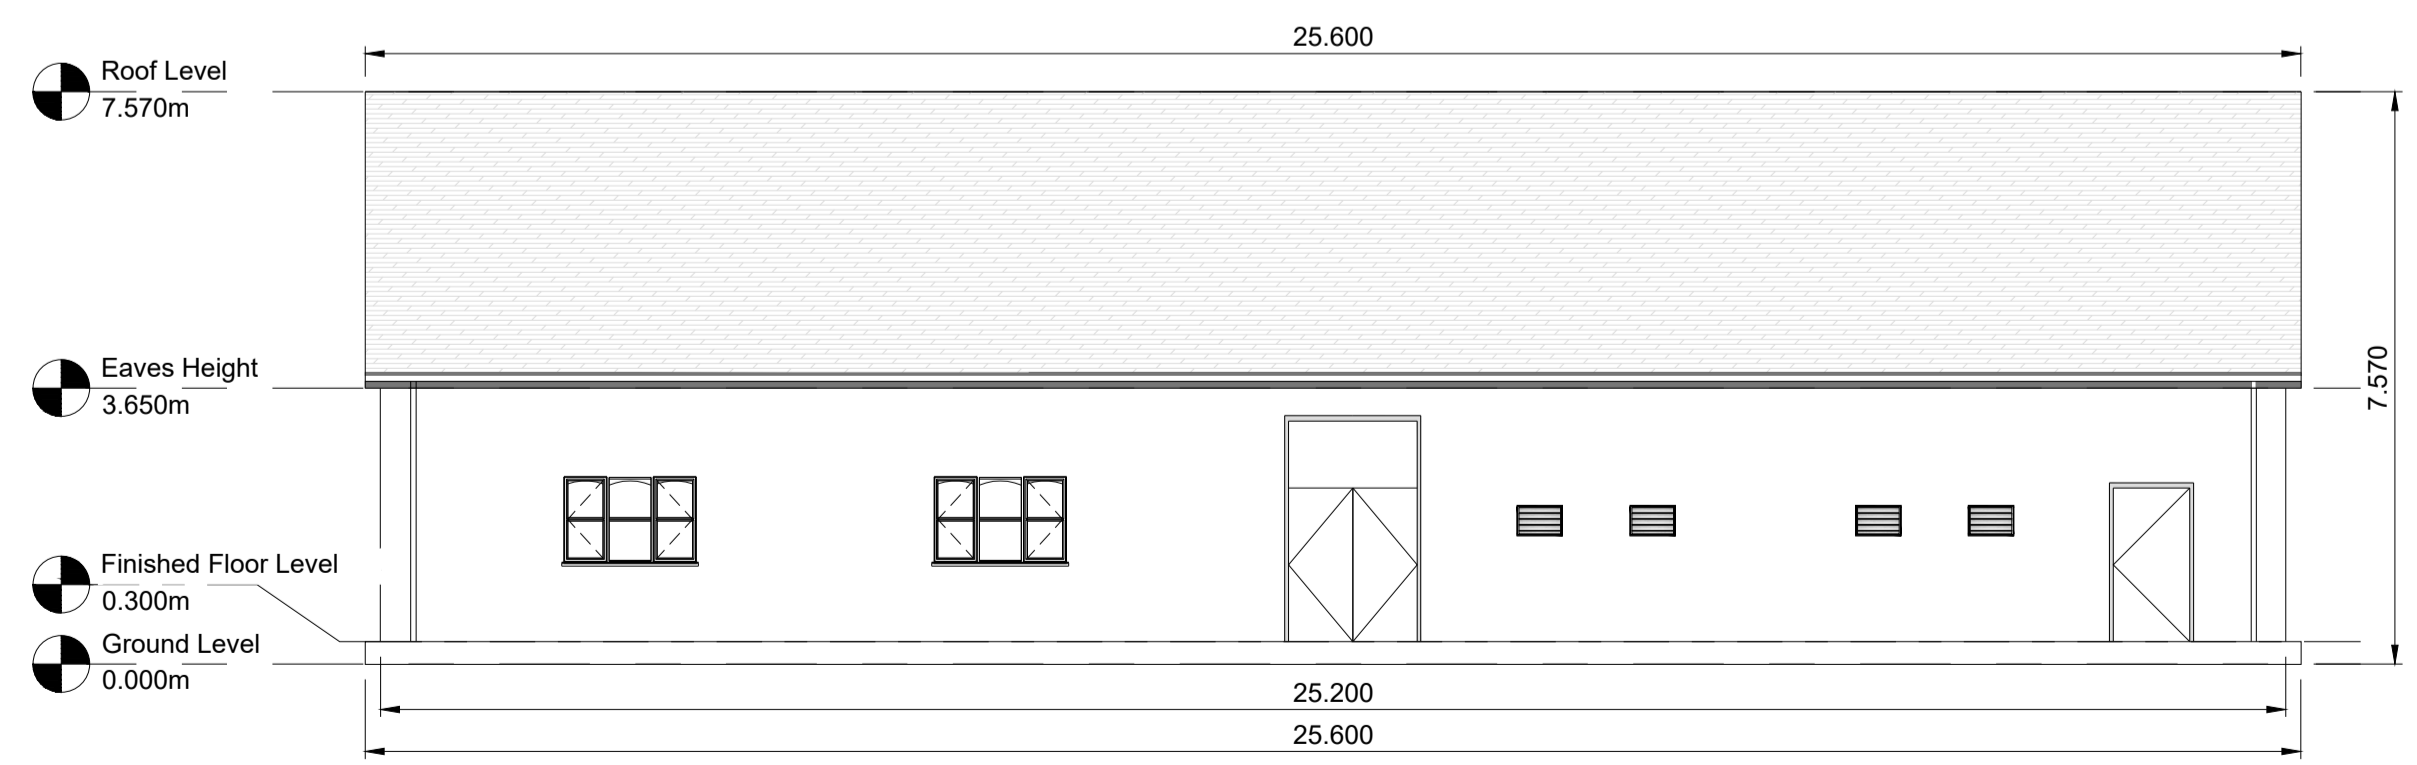


4 Substation Building South Elevation
Scale 1:100 @ A1

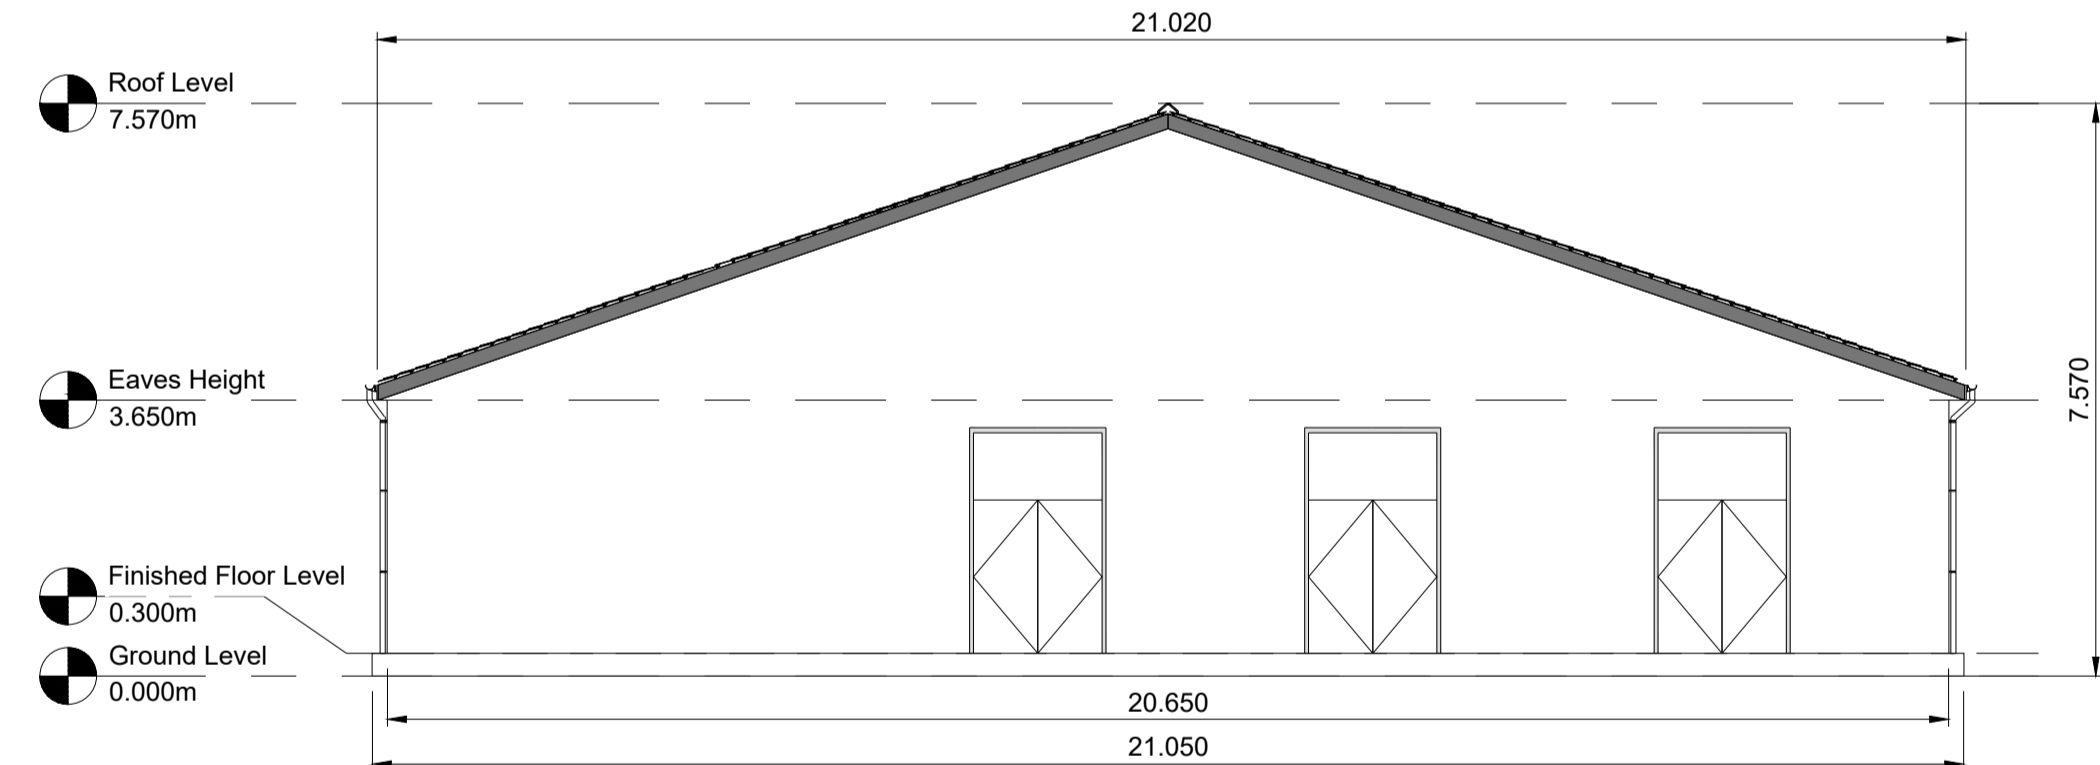

3 Substation Building East Elevation
Scale 1:100 @ A1

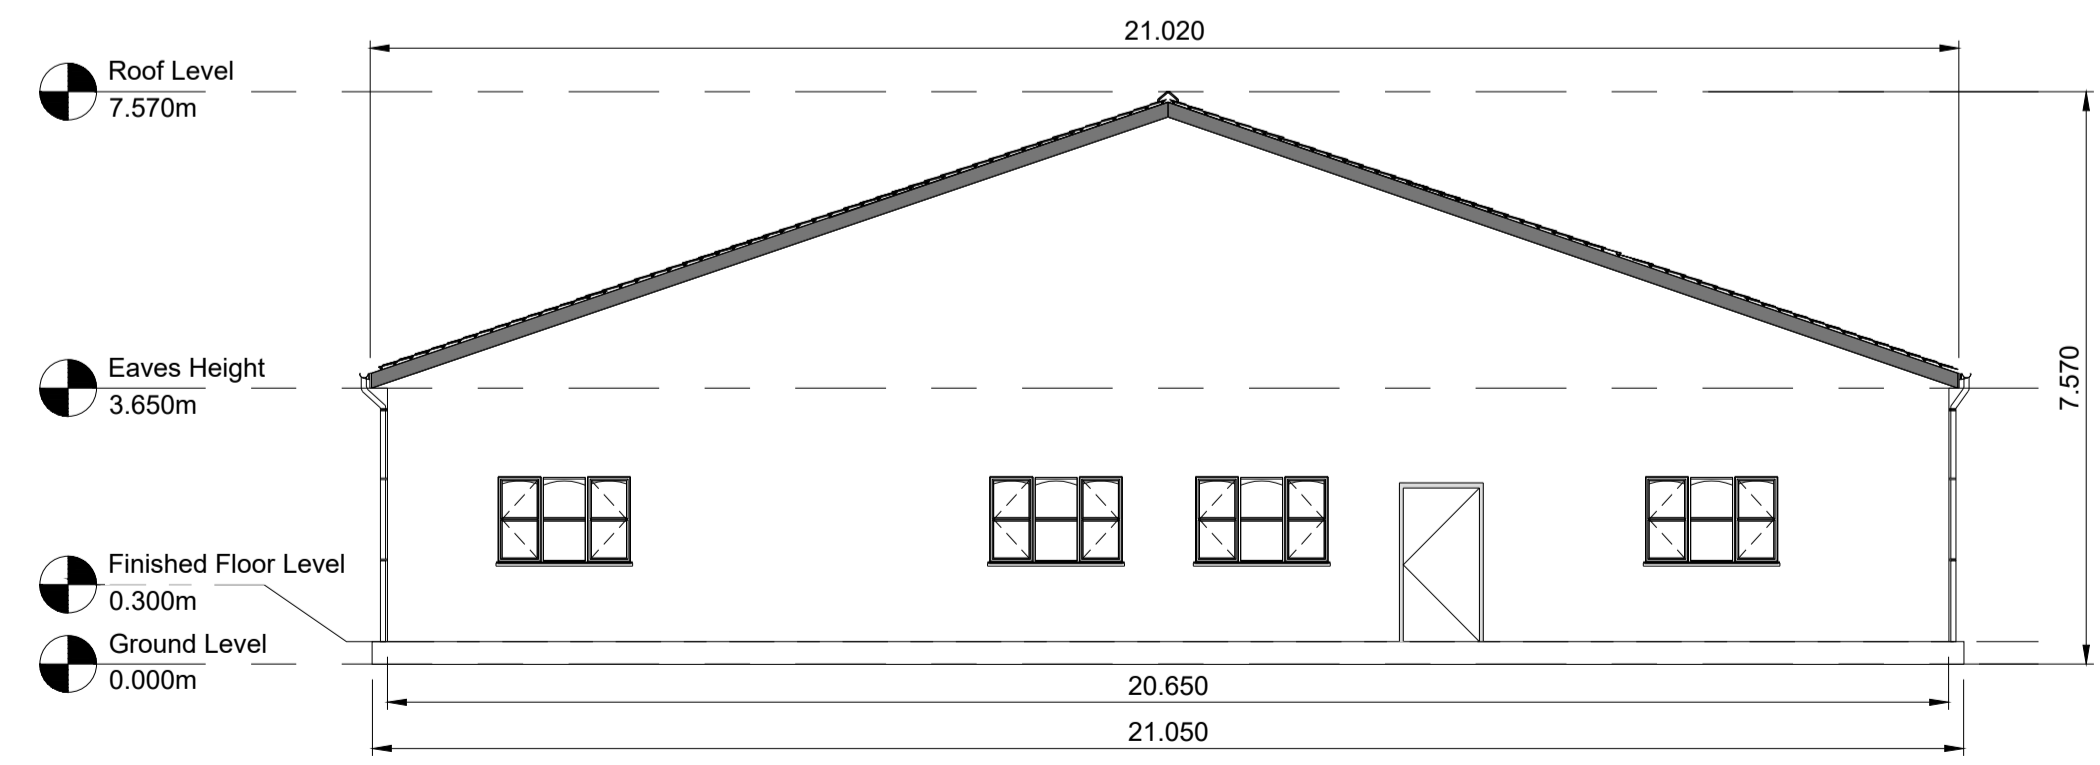

5 Substation Building West Elevation
Scale 1:100 @ A1

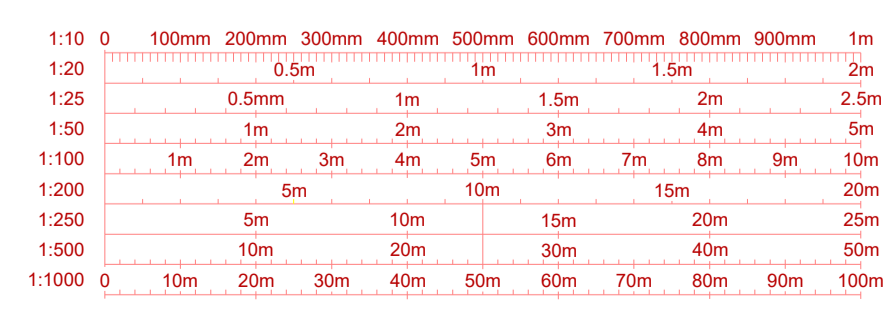

Drawing Notes

- All dimensions are shown in metres unless noted otherwise.
- Do not scale from this drawing.

REV	DATE	DESCRIPTION	BY	CHKD
1	19.06.2024	Drawing title and notes amended	JH	JM
0	05.06.2024	33kV Substation Plan and Elevations - Original	JH	EW

FIELD
Field
Fora Montacute Yards
186 Shoreditch High Street
London
E1 6HU

PROJECT: Knocknagael

TITLE: Substation Building Plan and Elevations

DISCIPLINE: PLANNING				
DRAWING STATUS: FOR PLANNING				
SCALE: 1:100 @ A1	DATE: 05.06.2024	DRAWN BY: JH	CHECKED BY: EW	APPROVED BY: JM
PROJECT NO: BTGBKN001	DRAWING NO: 004.1	REV: 01		